
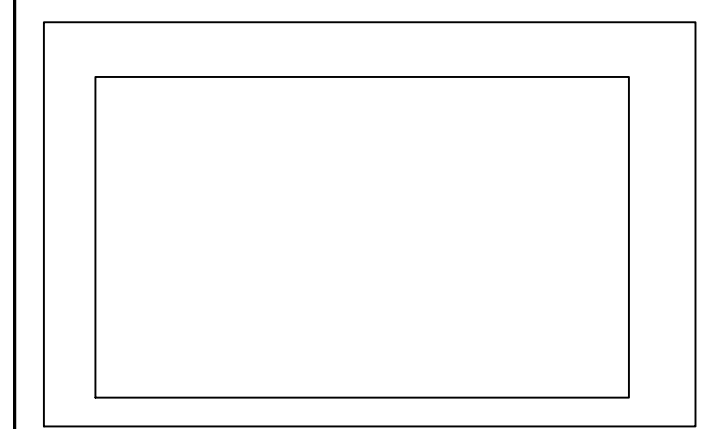
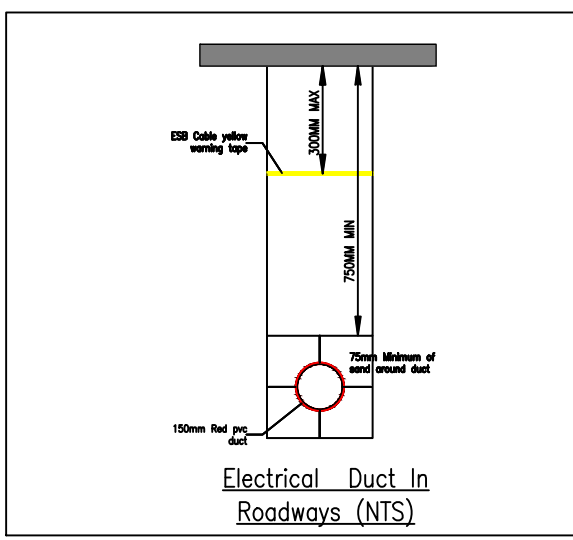


- NOTES:
1. ALL DRAWINGS ARE TO BE READ IN CONJUNCTION WITH ALL RELEVANT SPECIFICATIONS, BILLS OF QUANTITIES, ARCHITECTURAL SERVICES AND ENGINEERING DRAWINGS.
 2. ANY DISCREPANCIES BETWEEN THESE DOCUMENTS SHALL BE BROUGHT TO THE ATTENTION OF THE ENGINEER.
 3. ALL DIMENSIONS ARE IN MILLIMETRES, UNLESS NOTED OTHERWISE.
 4. ALL LEVELS ARE IN METRES RELATED TO ORDNANCE DATUM.
 5. DRAWINGS ARE NOT TO BE SCALED.

PUBLIC LIGHTING LEGEND:

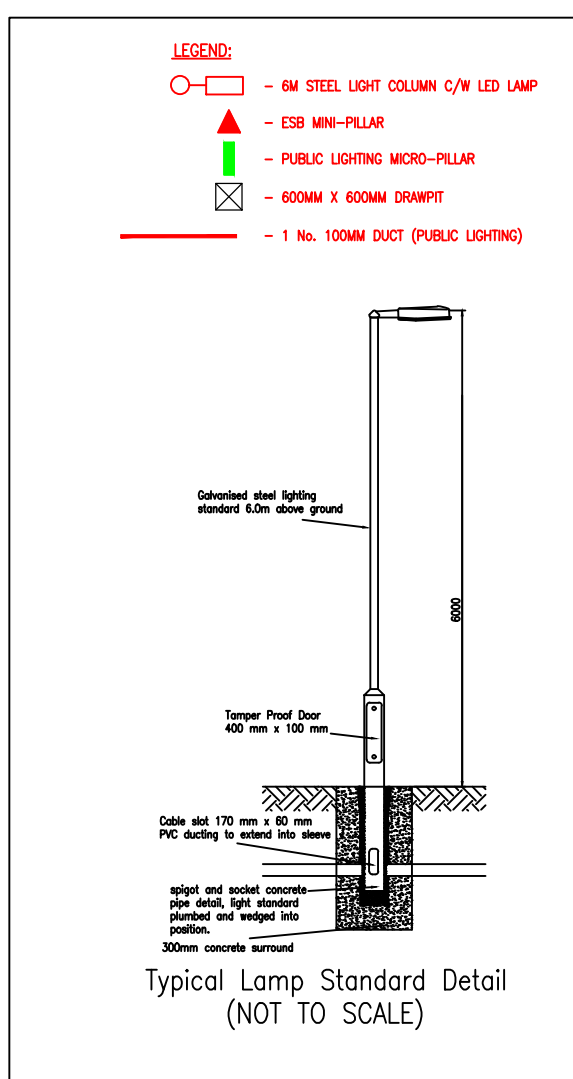

REV	DATE	DESCRIPTION	BY	APP
P01	29-08-23	ISSUE FOR PLANNING	J.K.	I.B.

PROJECT: CLOONMORE REGENERATION LRD, TRALEE, Co. KERRY.

TITLE: PUBLIC LIGHTING LAYOUT

CLIENT: TULFARRIS CG LTD



DRAWN: O.B.	CHECKED: J.K.	APPROVED: I.B.
PROJECT NUMBER: 23824	DATE: 25/08/2023	SCALE @ A1: 1:500
STATUS DESCRIPTION: FOR INFORMATION		STATUS: S2

DRAWING NUMBER: 23824 - MWP - 00 - 00 - DR - E - 9001	REV: P01
---	----------

PROPOSED SIGHT DISTANCE PLAN LAYOUT
SCALE: 1:500